


MARK	DATE	ISSUED	DESCRIPTION
0	8/14/12	ISSUED	
		ISSUE	



 

PROJECT NO: **89-30-38**
CAD DWG FILE: 89-30-38_E-SP-01.dwg
DRAWN BY: JMT
DESIGNED BY: JDK
CHECKED BY: HDT


SITE PLAN, LEGEND & INDEX

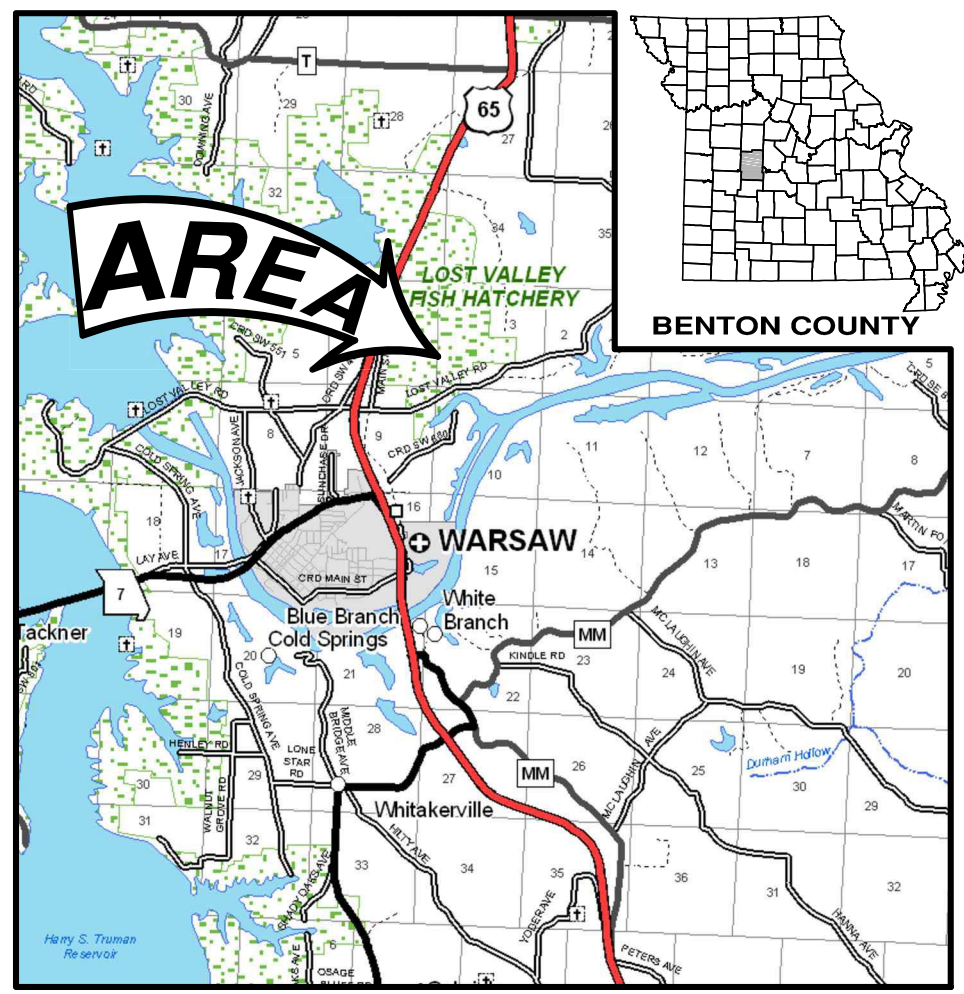

VICINITY MAP

LEGEND:

-  DETAIL NUMBER
-  DETAIL NUMBER AND SHEET FOUND
-  SECTION LINE CALLOUT WITH DETAIL AND SHEET NUMBER
-  ELEVATION CALLOUT WITH DETAIL AND SHEET NUMBER

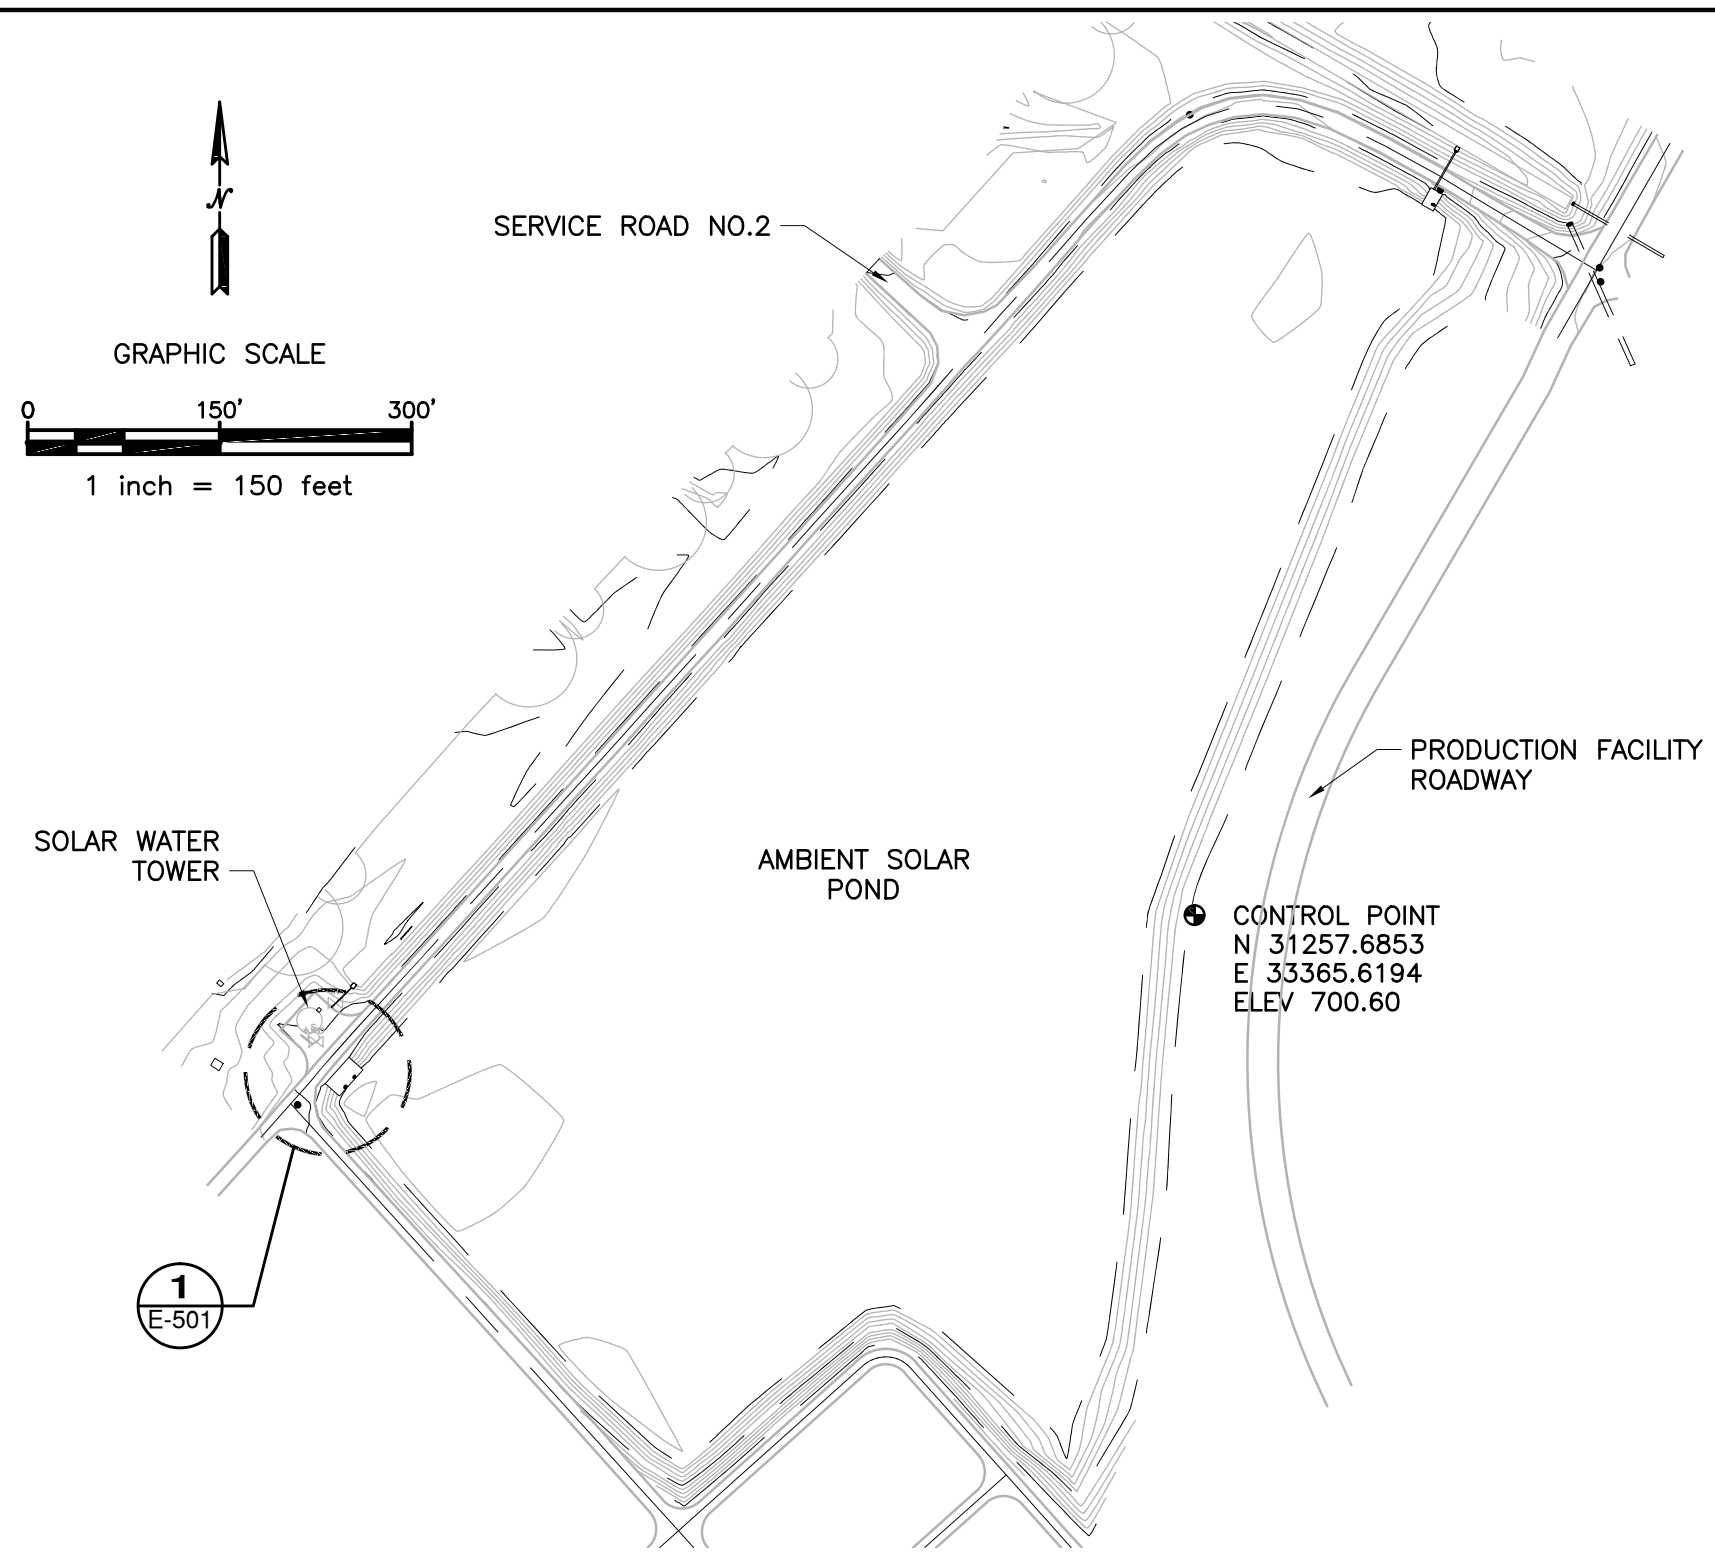

1 AMBIENT SOLAR POND - SITE PLAN
SCALE: 1" = 150'

DRAWING INDEX

SHEET	SHEET ID	TITLE
0	--	COVERSHEET
1	E-101	SITE PLAN, LEGEND & INDEX
2	E-102	ELECTRICAL DEMOLITION
3	E-501	ELECTRICAL DETAILS

